


ENLARGED SITE PLAN PHOTOMETRICS

SCALE: N.T.S.

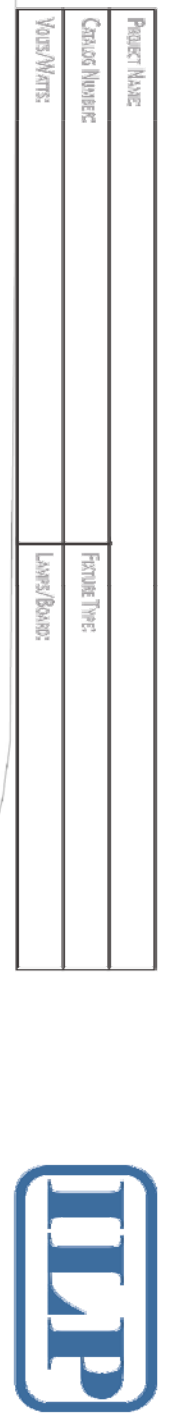

LOW PROFILE CANOPY - 40W LED
PARKING GARAGE
REPLACES 150W MH

- FEATURES**
- Die Cast Aluminum Housing
 - 3/8" Cast Rugs with Orbits for Conduct & Protection on
 - Textured Architectural Bronze Powdercoat Finish
 - Over a Chromia Conversion Coating
 - Mount Directly Over a 4" Recessed Outlet Box,
 - or Outside-Mount Bracket Option
 - Outside Mounting Bracket Options to Full Control
 - Custom Colors Available Upon Request
 - Conforms to ANSI 1989 Standards
 - 5 Year Warranty
 - ETL Listed for the Location
 - Designated for Commercial Qualified Luminaires™

LED SYSTEM

Board (CREE CHIP)	4 x 4
Driver (LUMILEX)	3.765 in
Total Input Voltage	42.62 V
Correlated Color Temperature (CCT)	5000 K
Max. Ambient Temp.	118°F
Universal Driver	120-277 V


ORDERING GUIDE:

Series	LED	Driver	Color	Options
CP	40W LED	UNIV	5000K	5000K
CP	Low Profile Canopy / 40W LED	40W Board	UNIV	120-277 Driver
			3000K	4000K
			5000K	5000K

- SUITABLE APPLICATIONS**
- Parking Garages
 - Freeways
 - Outdoor Areas

Call us today! www.lpf-h.com 407-478-3799



LOW PROFILE CANOPY - 40W
PARKING GARAGE

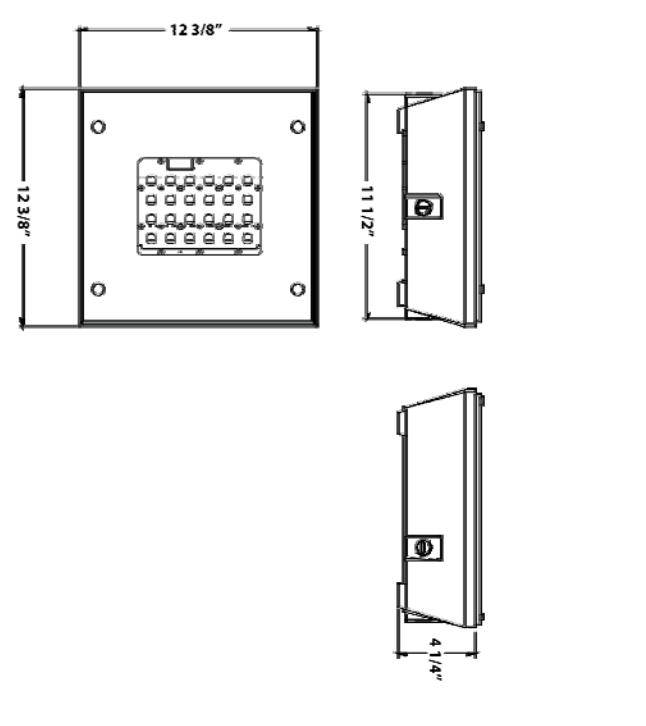

MOUNTING OPTIONS



QMB 16-gauge stainless steel surface mount or over-recessed electrical box.

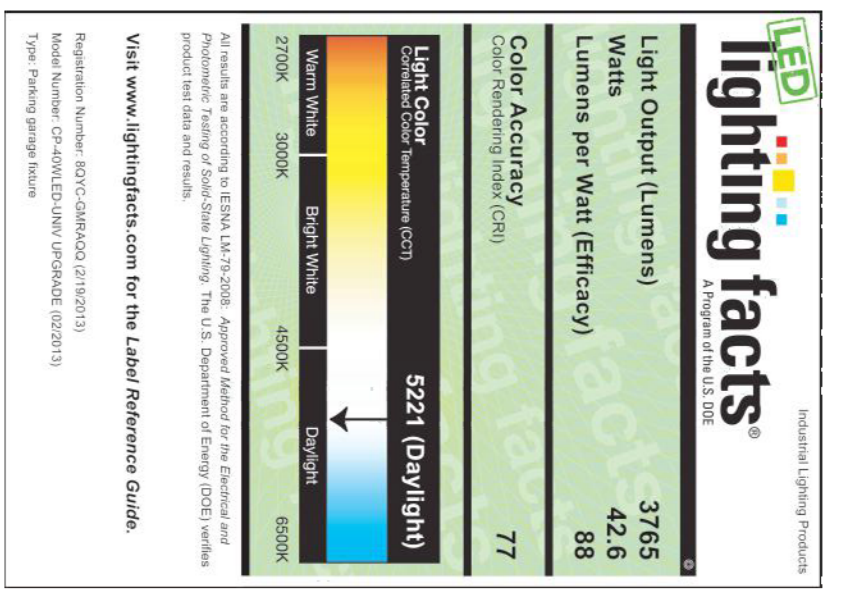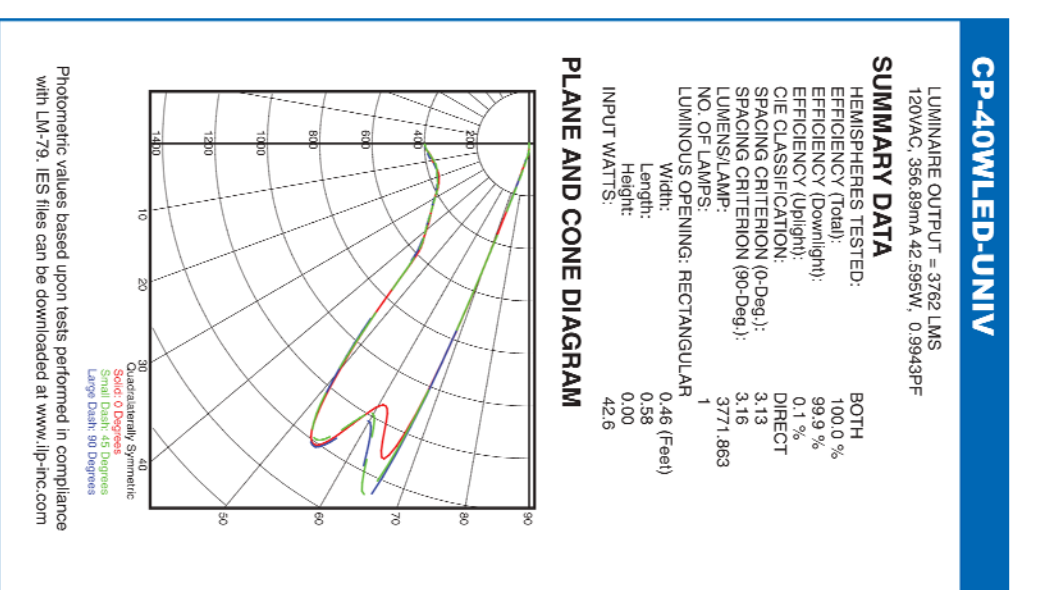

LUMINAIRE SCHEDULE

TAG	MANUFACTURER & CATALOG NUMBER	DESCRIPTION	MTG.	LAMP		VOLTS	WATTS	NO. OF FIXTURES
				TYPE	No.			
A	ILP LIGHTING CP-40WLED-UNIV-5000K-QMB-DIM-FSP-211	UNDER CANOPY LIGHT	SURFACE			277	426	60



NORTH

2100 west 15th street
tempe, arizona 85281-6942
tel: 480.285.3800
fax: 480.285.3801



CN4901
MANTECA HOSPITAL
1777 WEST YOSEMITE AVENUE
MANTECA, CALIFORNIA 95337

KAISER PERMANENTE PV SOLAR PROJECT

Revisions

Project Number
5954-100B0.10
Date
6.16.17
Drawn By
FM
Checked By
JW

ENLARGED SITE PLAN
E-PH1.0